

NOTES:


(VAE-ROOM) WITH DIRECT CONNECTION TO BUILDING VENTILATION SYSTEM.

- REFER TO DRAWING'S 011B308, 011B315, 011B249C, 011B301, & 011B251C FOR VAE-ROOM DETAIL.
- THE STANDARD VAE-ROOM IS WITHOUT THE OPTIONAL FLOOR SYSTEM.
- VERTICAL & HORIZONTAL CLOSURES ARE INCLUDED IN THIS PLAN.
- (E) = INDICATES APPROXIMATE LOCATION OF 115V - 20AMP, 60HZ HOUSE SERVICE. REFER TO DWG. 011B251C.
- RECOMMEND INSTALLATION OF VAE-ROOM PRACTICE OVER FINISHED FLOORS.
- THE DOOR INSERT COLOR CHOICE TO BE SELECTED FROM WEDGEWOOD, BLACK, RASPBERRY, PEBBLE, OYSTER, CHARCOAL OR PRIMER GRAY.
- THE AREA SURROUNDING THE VAE-ROOM IS TO BE MAINTAINED AT 75 DEGREES FAHRENHEIT. THE AIR SUPPLIED TO THE ROOM IS TO BE MAINTAINED AT 55 DEGREES FAHRENHEIT. SCHEDULED AIR QUANTITIES DO NOT INCLUDE EQUIPMENT LOADS FOR AMPLIFIERS, SYNTHESIZERS ETC. TO MAINTAIN ADEQUATE INDOOR AIR QUALITY WITHIN VAE-ROOM AND TO COMPLY WITH CURRENT CODE REQUIREMENTS, A MINIMUM OF 15 C.F.M. OF OUTSIDE AIR PER OCCUPANT MUST BE PROVIDED AS A PORTION OF THE SUPPLY AIR.
- IF ELECTRICAL EQUIPMENT IS TO BE USED IN THE VAE-ROOM, IT WILL REQUIRE AN ADDITIONAL 15 C.F.M. OF 55 DEGREE AIR FOR EACH 100 WATTS OF POWER USED WITHIN THE ROOM.
- A MEANS OF CONTROLLING THE TEMPERATURE OF THE AIR BEING DELIVERED TO THE ROOM SHOULD BE PROVIDED, TO BE DONE BY OTHERS, IF NOT THE ROOMS MAY OVERCOOL WHEN USED BY FEWER THAN THE LISTED NUMBER OF OCCUPANTS.
- WENGER H.V.A.C. ADAPTER HAS AN 8" DIA. PORT. THE CONNECTION, TO BE MADE BY OTHERS, MUST HAVE A FLEX DUCT.
- MAX. HEIGHT OF HORIZONTAL CLOSURES SUPPLIED BY WENGER IS 24".
- HEIGHT OF ROOMS FROM FINISHED FLOOR TO TOP OF HVAC ADAPTER IS 8'-6 1/2". WENGER RECOMMENDS A MIN. CEILING CLEARANCE OF 10'-7" FOR INSTALLATION OF HVAC CONNECTIONS.

| WENGER ROOM SPECIFICATIONS | | | | | | |
|----------------------------|--------------------|------------------------------|----------------|-----------------|-----|-------------------------|
| ROOM NO. | WENGER PRODUCT NO. | MIN. REQ'D CEILING CLEARANCE | TOTAL AMP DRAW | RATED OCCUPANTS | CFM | TOTAL NO. OF HVAC PORTS |
| A | R071166 | 10'-7" | 6.2 | 6 | 170 | 4 |
| B | R071166 | 10'-7" | 6.2 | 6 | 170 | 4 |
| | | | | | | |
| | | | | | | |
| | | | | | | |

NOTES:

- THE LAST TWO DIGITS OF THE WENGER PRODUCT NO. INDICATES VAE, V-READY ROOMS, OR NON-UPGRADEABLE. 66 = VAE, 52 = V-READY AND 62 = NON-UPGRADEABLE.
- TOTAL NO. OF HVAC PORTS INCLUDES EQUAL QTYS OF INTAKE AND EXHAUST CONNECTIONS.

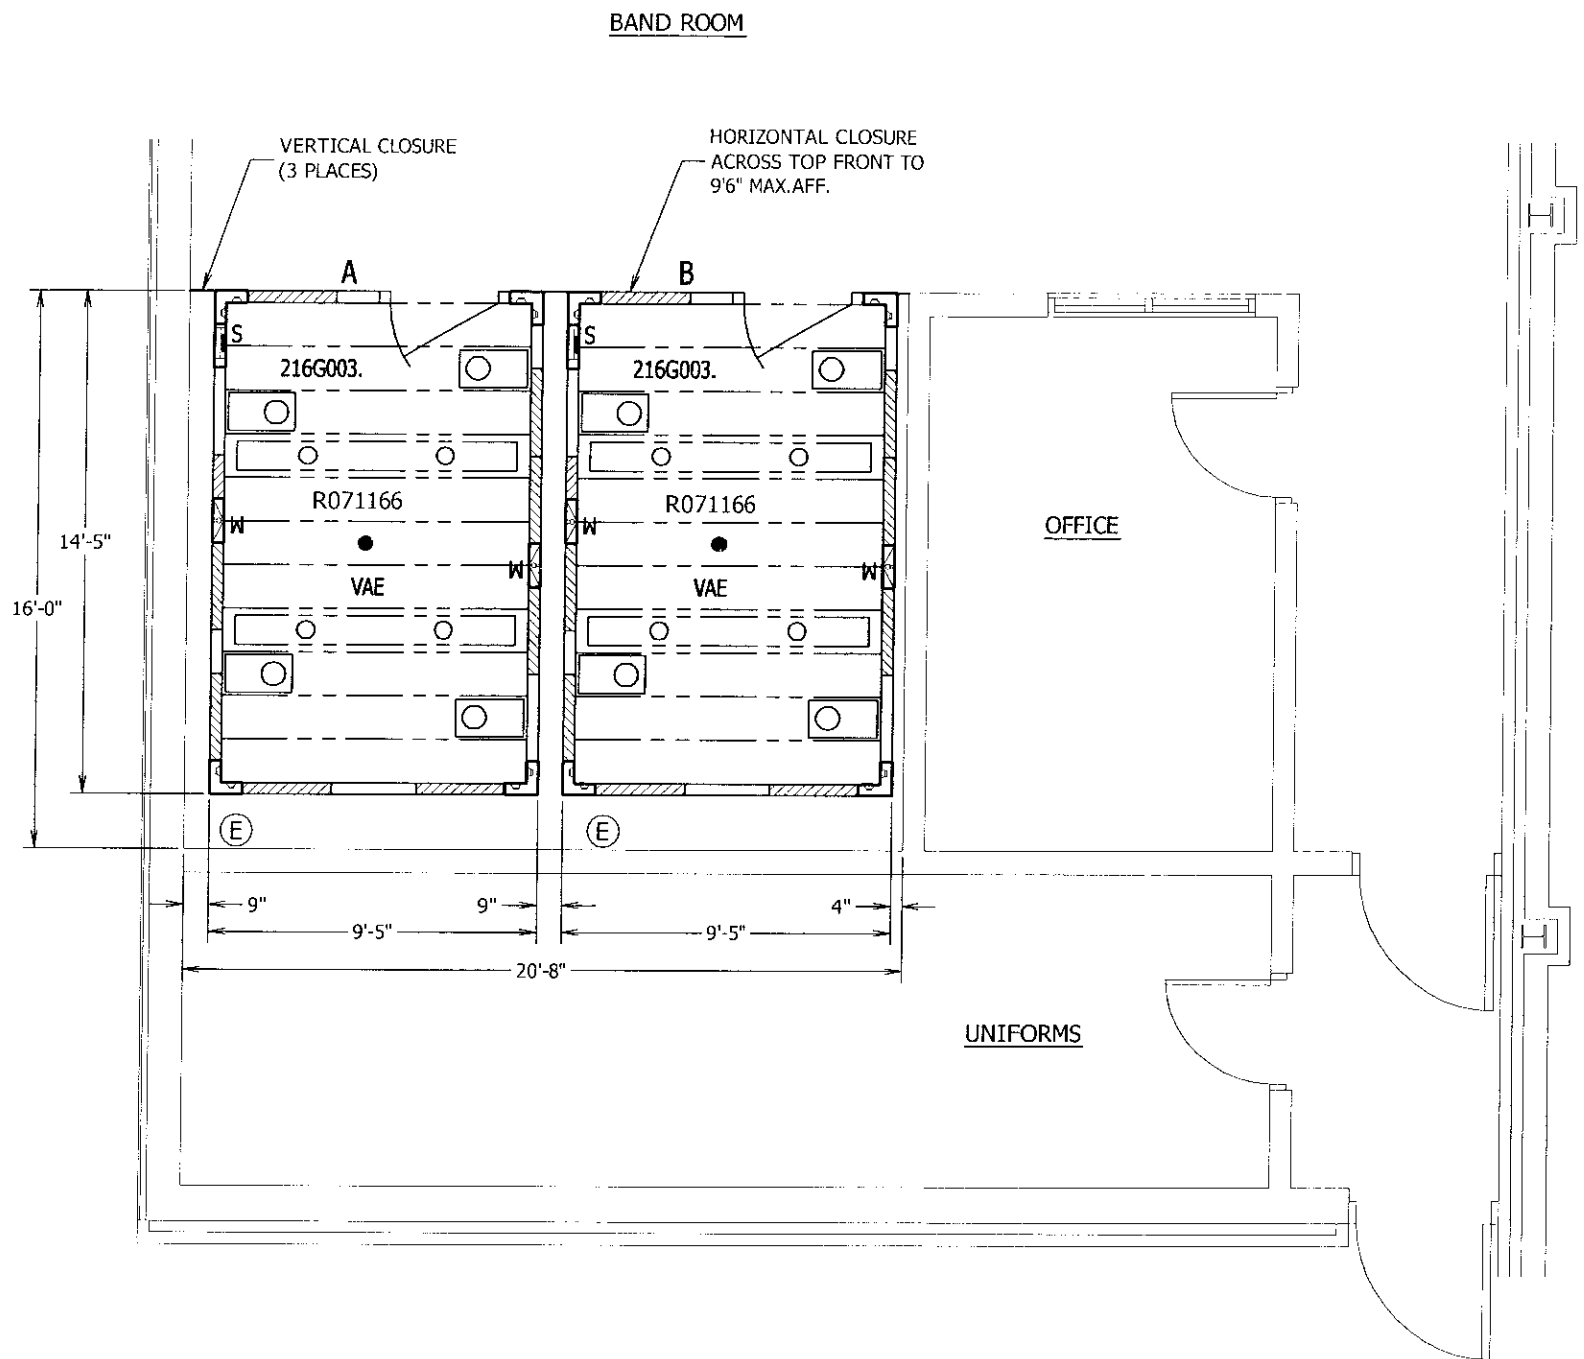

| | | | | | | | |
|-----------|-------|---------------------------------------------------------------------------------|--------------------------------------------------------------------------------------------------------------------------------------------------------------------------------------------------|-------------------------------------|----------------------|--------------------|---------------------------------------|
| REVISIONS | LEVEL | PREPARED FOR: | For Tolerance Specifications see: | For Engineering Specifications see: | Finish Instructions: | Sheet Size: | |
| | | BUCKEYE VALLEY HIGH SCHOOL DELAWARE, OH 43015 | ES52002 | | B | | |
| | | TITLE: | Workmanship Standards Document see: | DATE: | DRAWN BY: | CHECKED BY: | OWATONNA, MN - TELEPHONE 507-455-4100 |
| | | SOUND ISOLATED PRACTICE ROOMS WITH VAE FLOOR PLAN PROPOSAL-BAND ROOM | PCD-0009 | 10/05/2009 | TV | | DWG. NO. SHEET 1 OF 1 REV. |
| | | | The Information contained in this drawing is the sole property of WENGER CORPORATION. Any reproduction in part or as a whole without the written permission of WENGER CORPORATION is prohibited. | | W/O NUMBER: | SCALE: 3/16"=1'-0" | 17055M101 |